
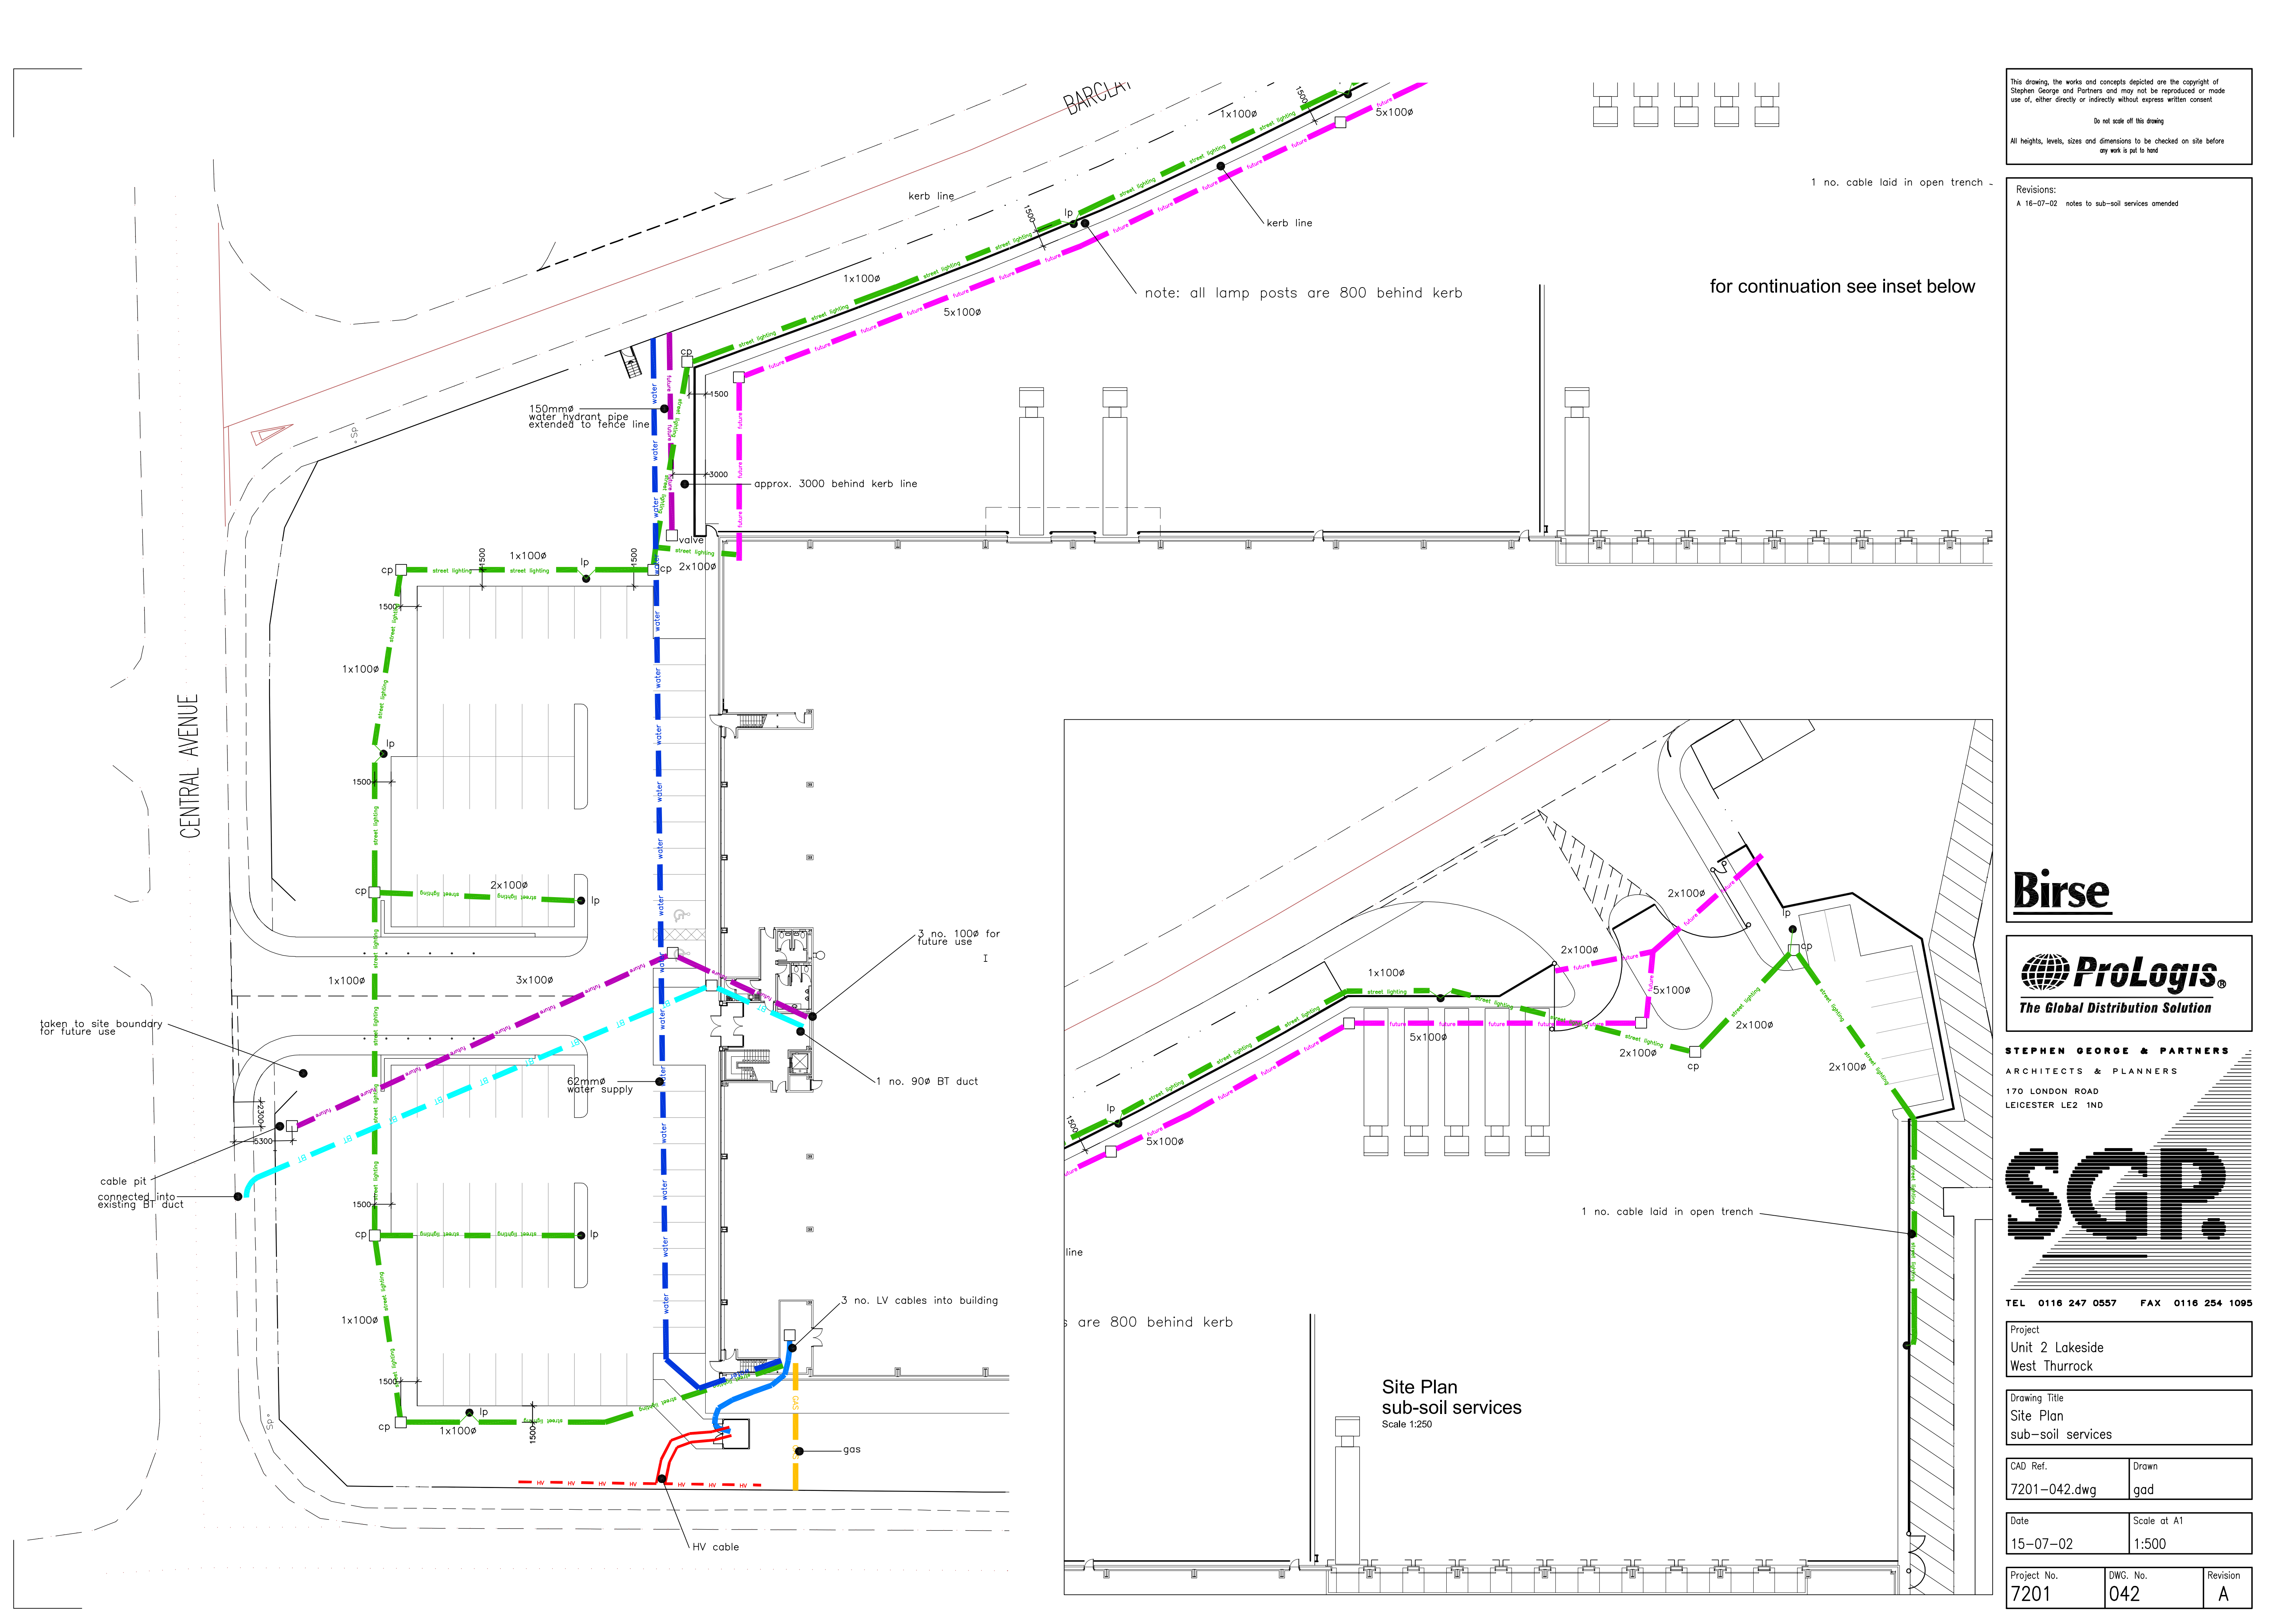


1 no. cable laid in open trench -

note: all lamp posts are 800 behind kerb

for continuation see inset below

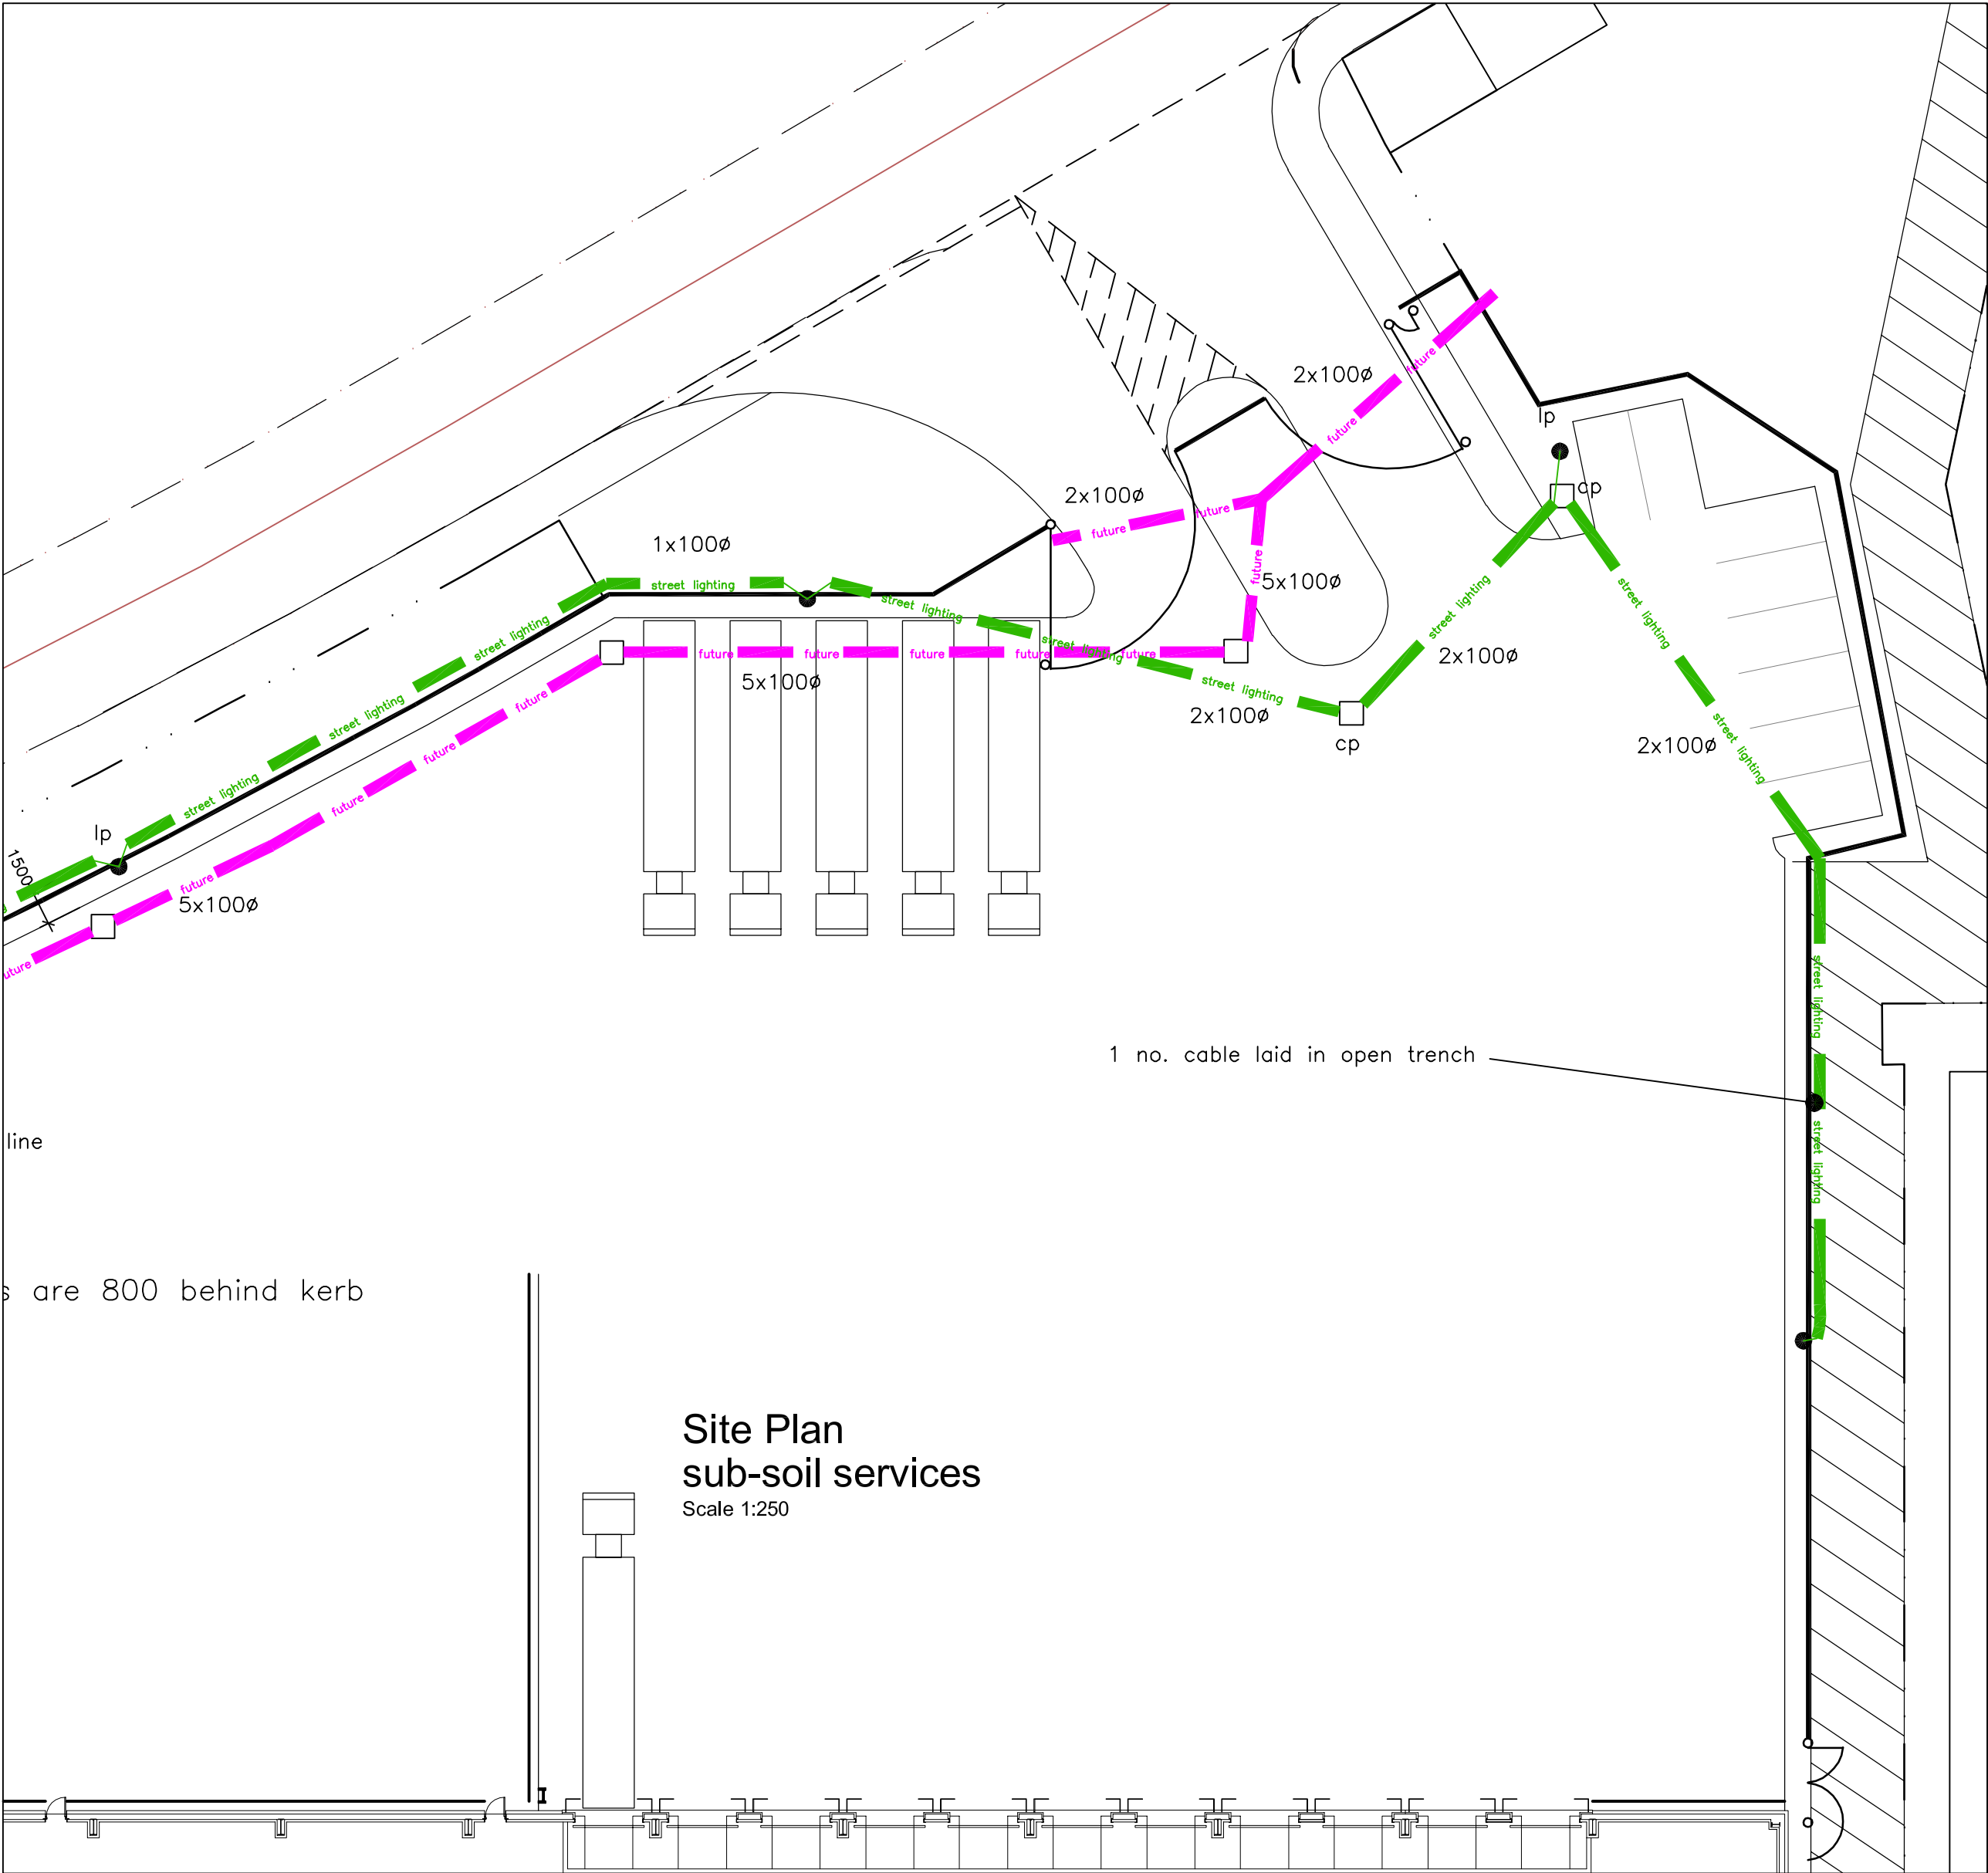

This drawing, the works and concepts depicted are the copyright of Stephen George and Partners and may not be reproduced or made use of, either directly or indirectly without express written consent

Do not scale off this drawing

All heights, levels, sizes and dimensions to be checked on site before any work is put to hand

Revisions:

A 16-07-02 notes to sub-soil services amended

Birse

ProLogis
The Global Distribution Solution

STEPHEN GEORGE & PARTNERS
ARCHITECTS & PLANNERS
170 LONDON ROAD
LEICESTER LE2 1ND

SGP.

TEL 0116 247 0557 FAX 0116 254 1095

Project
Unit 2 Lakeside
West Thurrock

Drawing Title
Site Plan
sub-soil services

CAD Ref. 7201-042.dwg
Drawn gad

Date 15-07-02
Scale at A1 1:500

Project No. 7201
DWG. No. 042
Revision A